






 
 





ELECTRICAL LEGEND

	FLURO LIGHT		SINGLE POWER OUTLET
	SPEAKER (ceiling mount)		DOUBLE POWER OUTLET
	PHONE POINT		CONTROL PANEL/SWITCH

"FUNCTION / DINING ROOM"

DRAWING SCALE 1 : 100

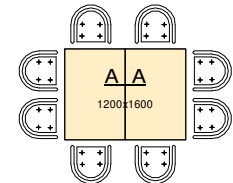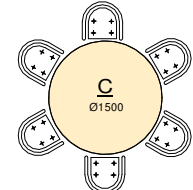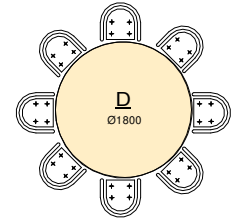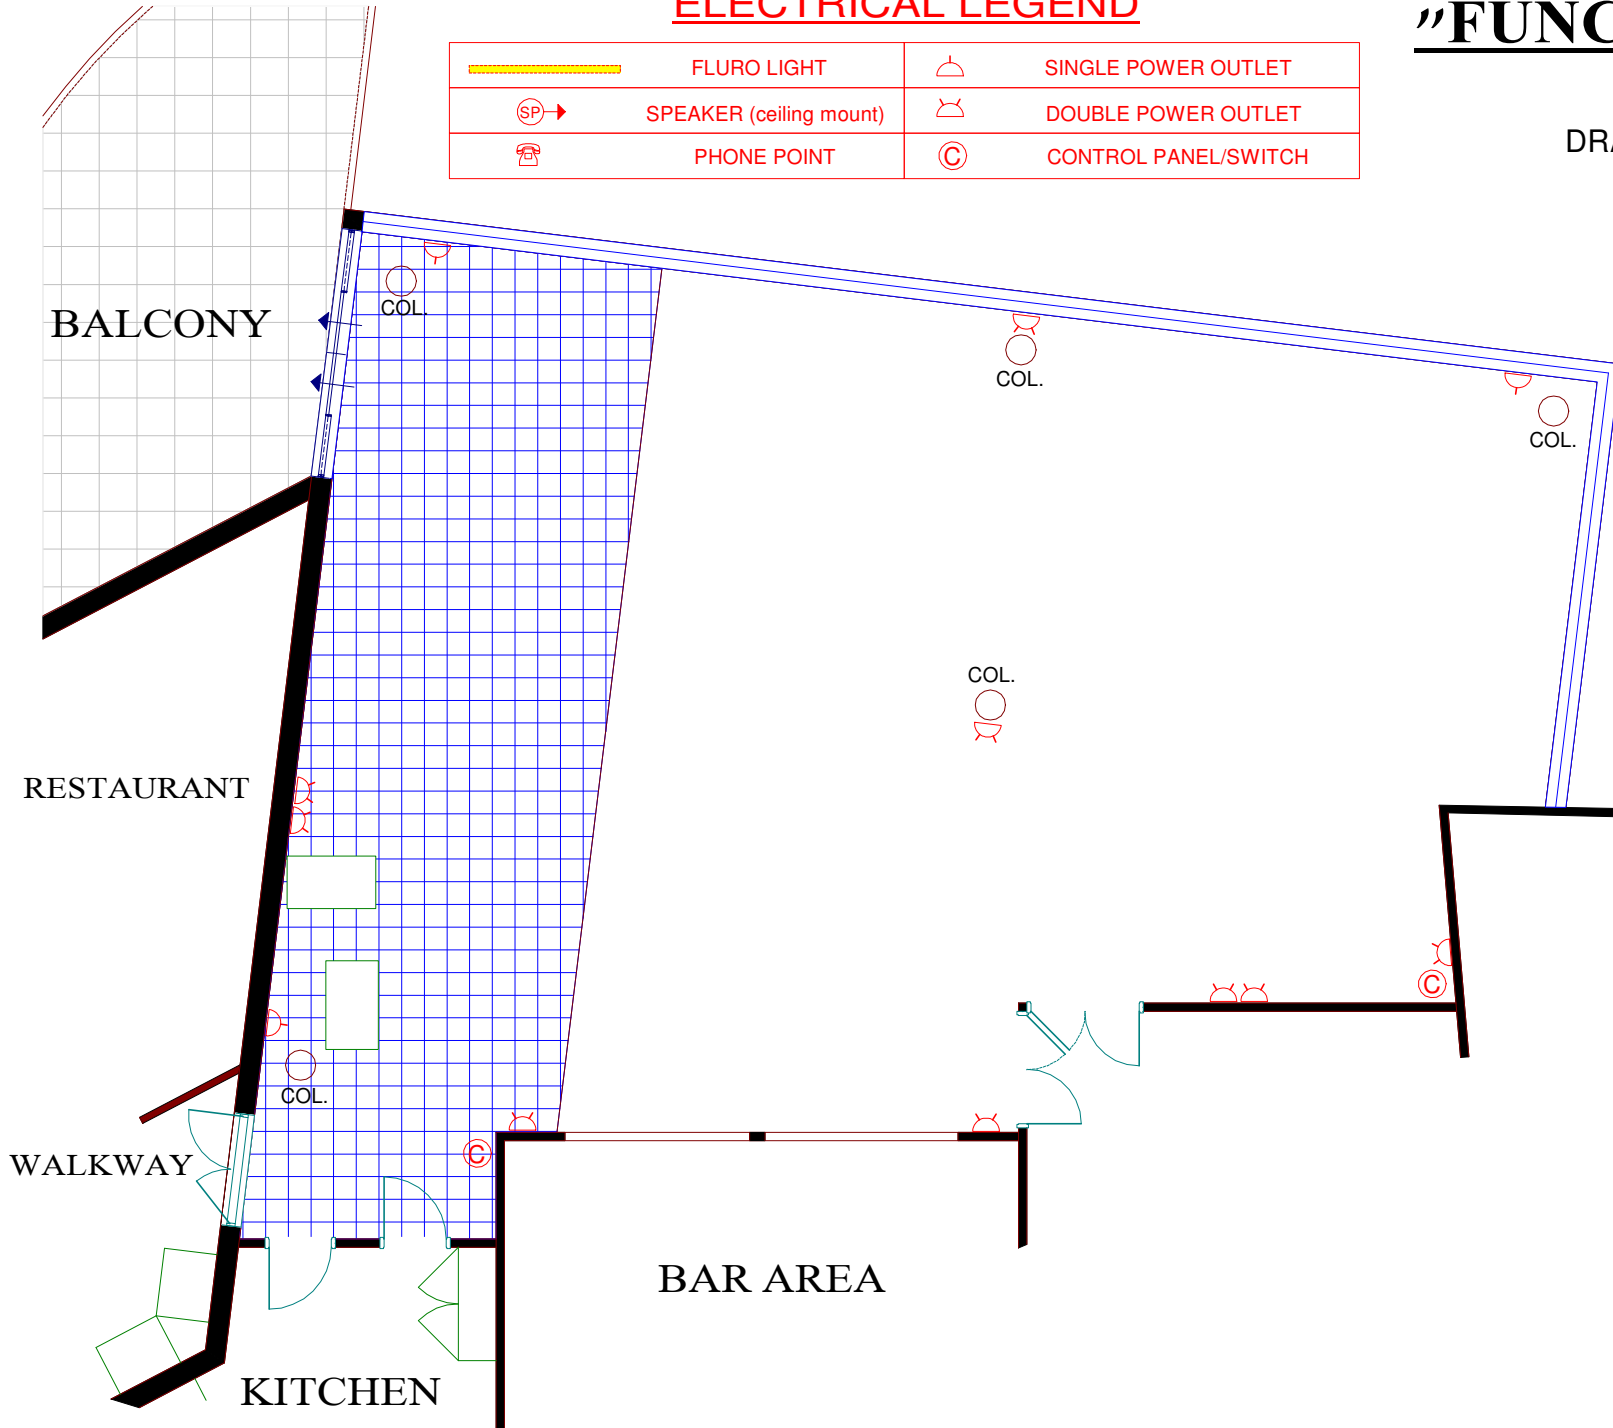

SEATING OPTIONS



ALL DIMENSIONS SHOWN ARE APPROX. ONLY AND MAY VARY SLIGHTLY